




**RIGHT ELEVATION**  
1/16" = 1'-0"

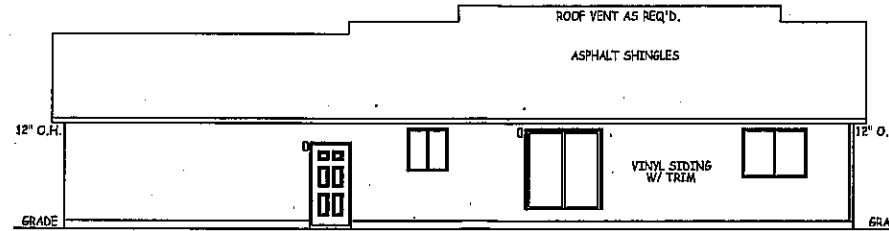

**REAR ELEVATION**  
1/16" = 1'-0"

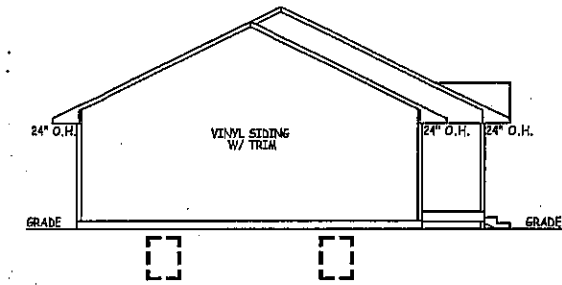


**LEFT ELEVATION**  
1/16" = 1'-0"

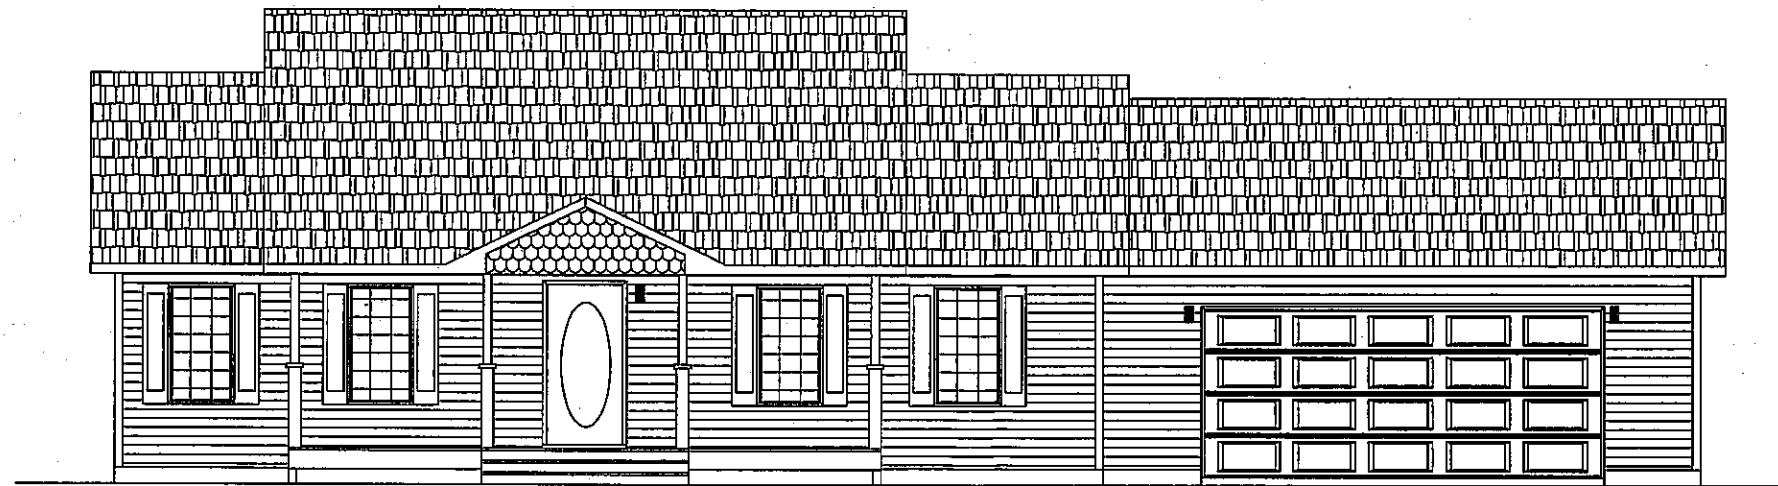

**FRONT ELEVATION**  
1/8" = 1'-0"


<b>HILLTOP LUMBER, Inc.</b>	
GLENWOOD, MN (320) 634-5386	ALEXANDRIA, MN (320) 763-9663
SCALE: AS NOTED	DRAWN BY: CLINT
DATE: 8/16/05	
RESIDENCE FOR: THE ALEXANDRA 2	
DRAWING NUMBER: 1 OF 1	

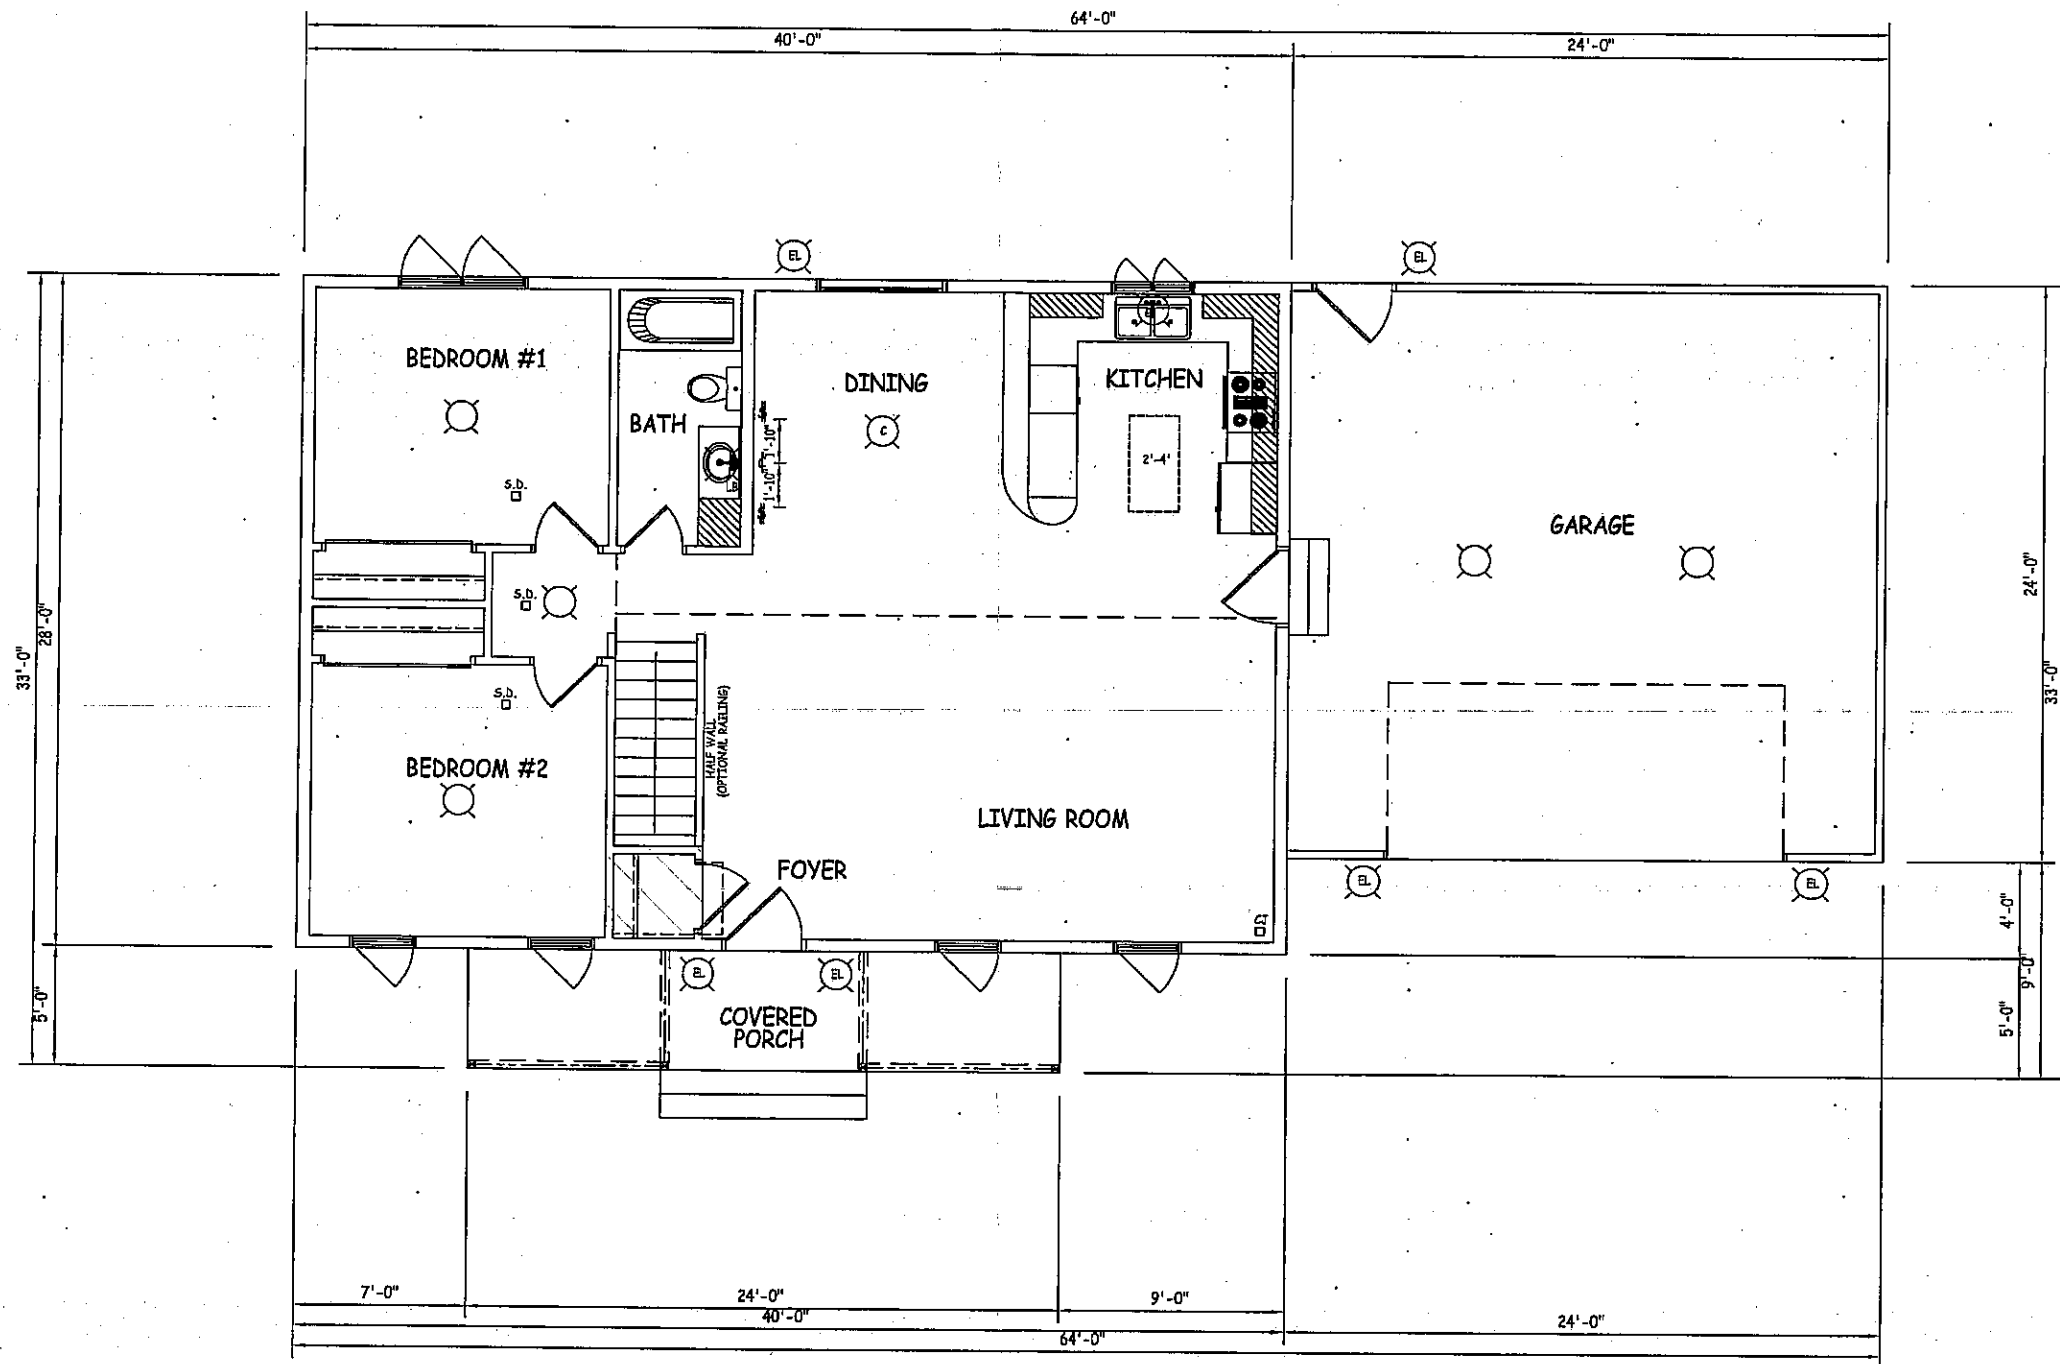

# MAIN LEVEL ELECTRICAL PLAN

1/8" = 1'-0"

<b>HILLTOP LUMBER, Inc.</b>	
GLENWOOD, MN (320) 634-5386	ALEXANDRIA, MN (320) 763-9663
SCALE: AS NOTED	DRAWN BY: CLINT
DATE: 8/16/05	
RESIDENCE FOR: THE ALEXANDRA 2	
	DRAWING NUMBER: 5 OF 5

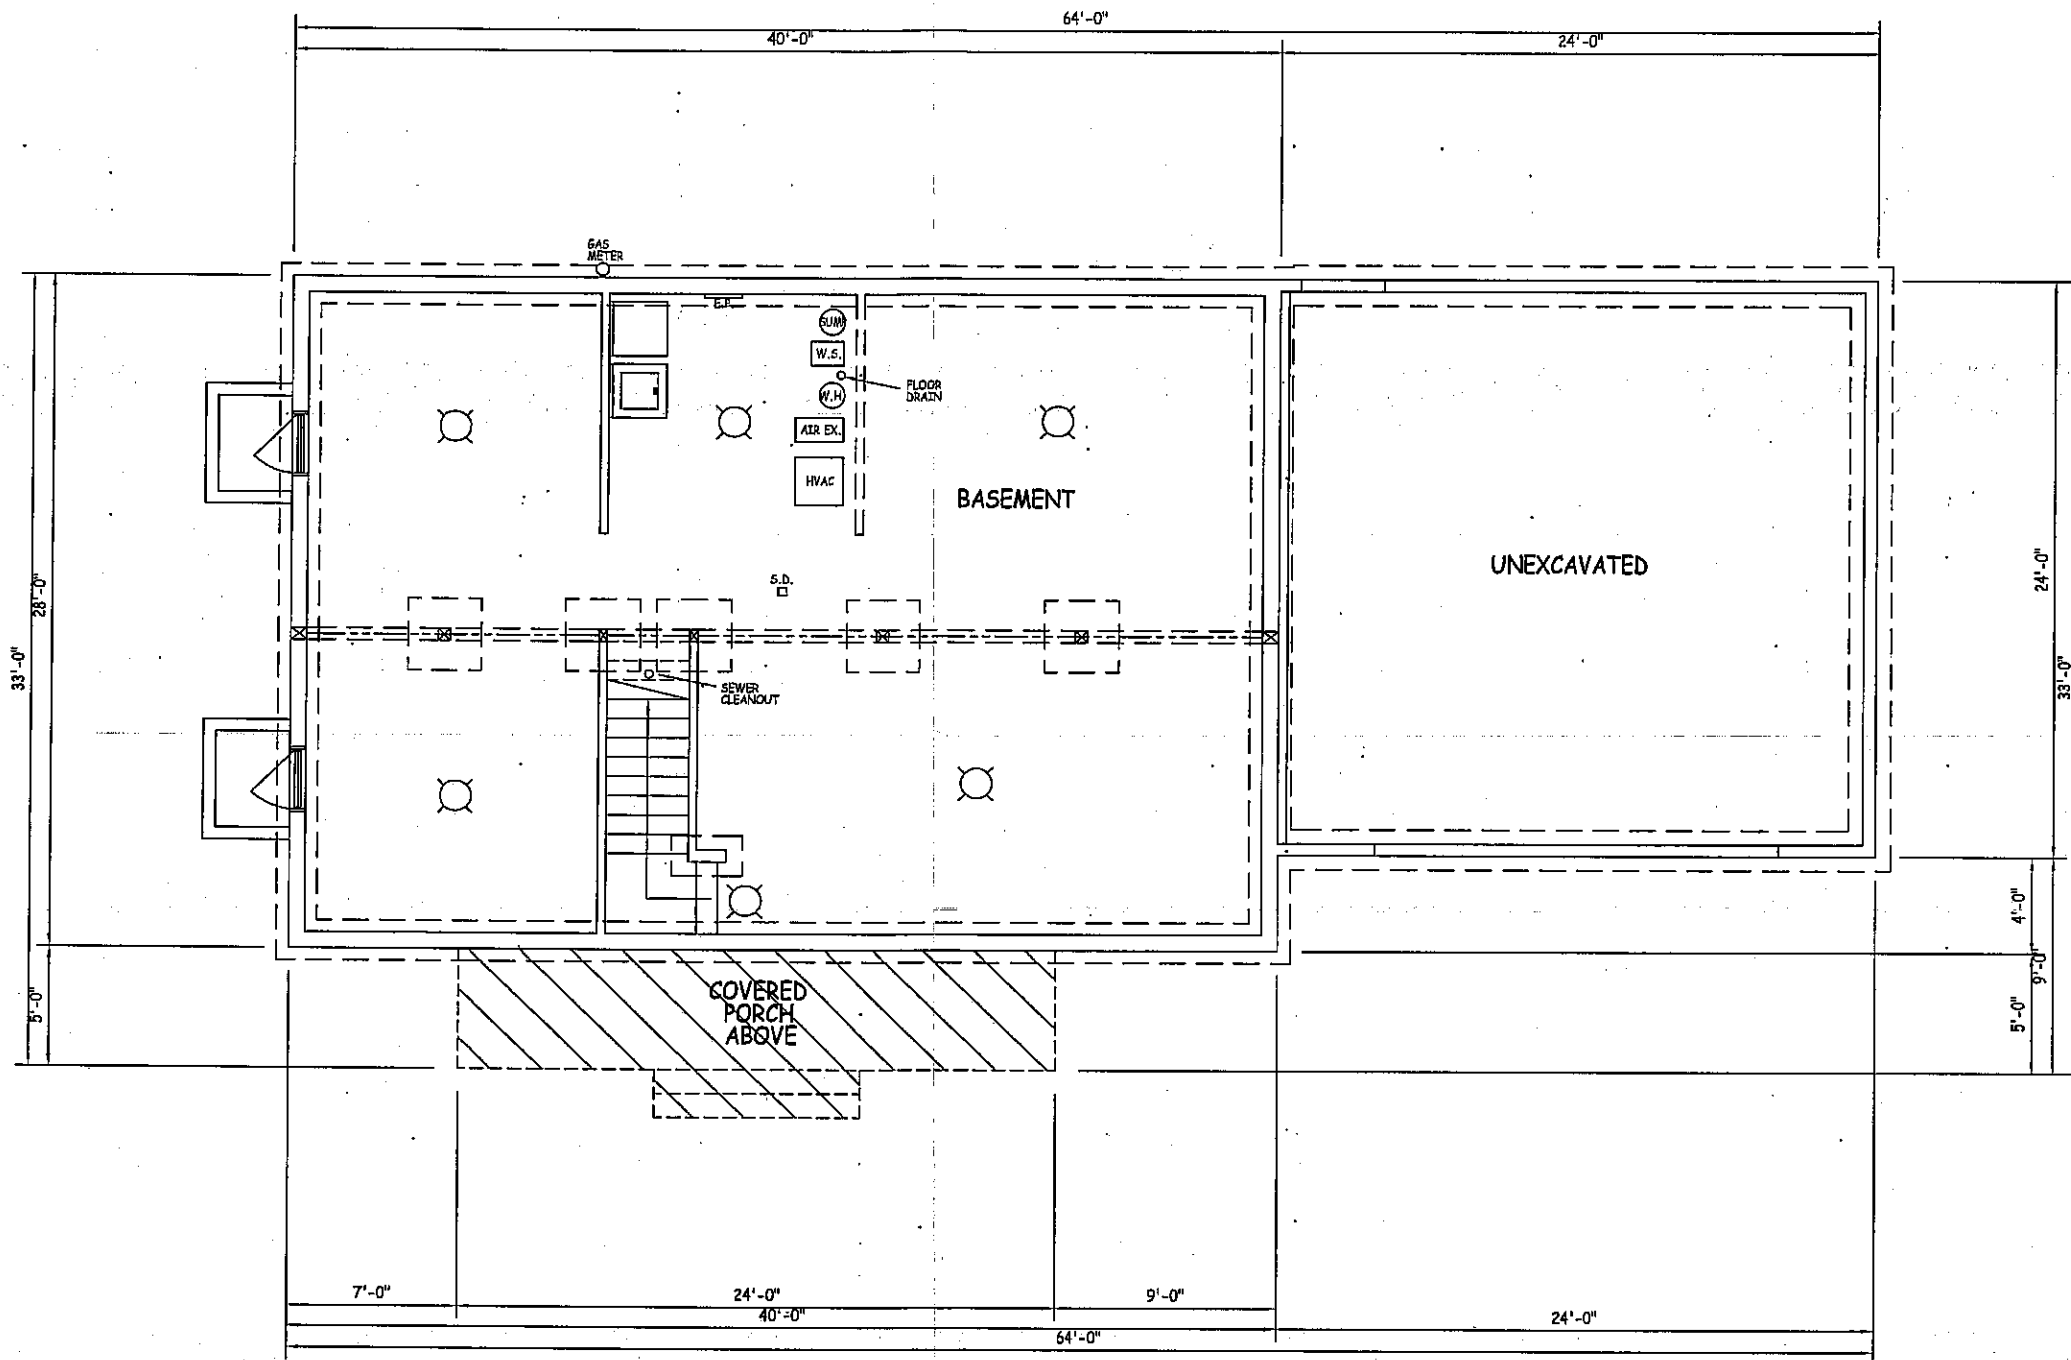

# FOUNDATION ELECTRICAL PLAN

1/8" = 1'-0"

<b>HILLTOP LUMBER, Inc.</b>	
GLENWOOD, MN (320) 634-5386	ALEXANDRIA, MN (320) 763-9663
SCALE: AS NOTED	DRAWN BY: CLIENT
DATE: 8/16/05	
REFERENCE FOR: THE ALEXANDRA 2	
DRAWING NUMBER: 6 OF 6	