




RIGHT ELEVATION
1/16" = 1'-0"

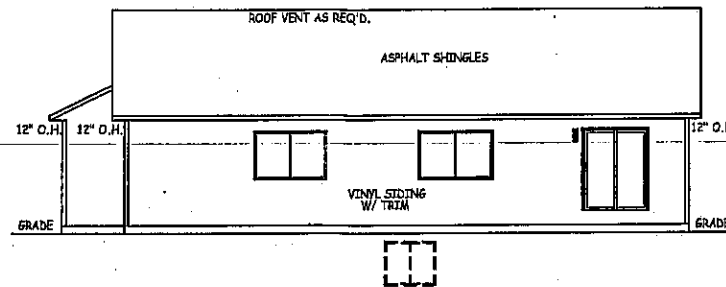

REAR ELEVATION
1/16" = 1'-0"

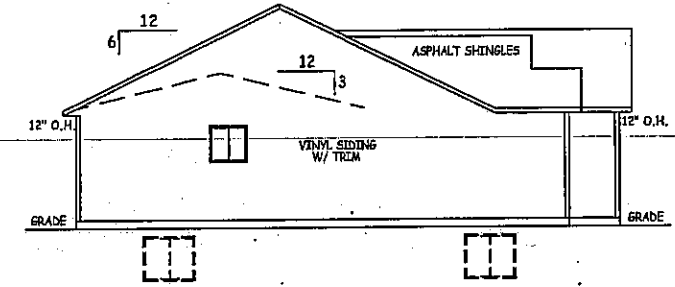


LEFT ELEVATION
1/16" = 1'-0"

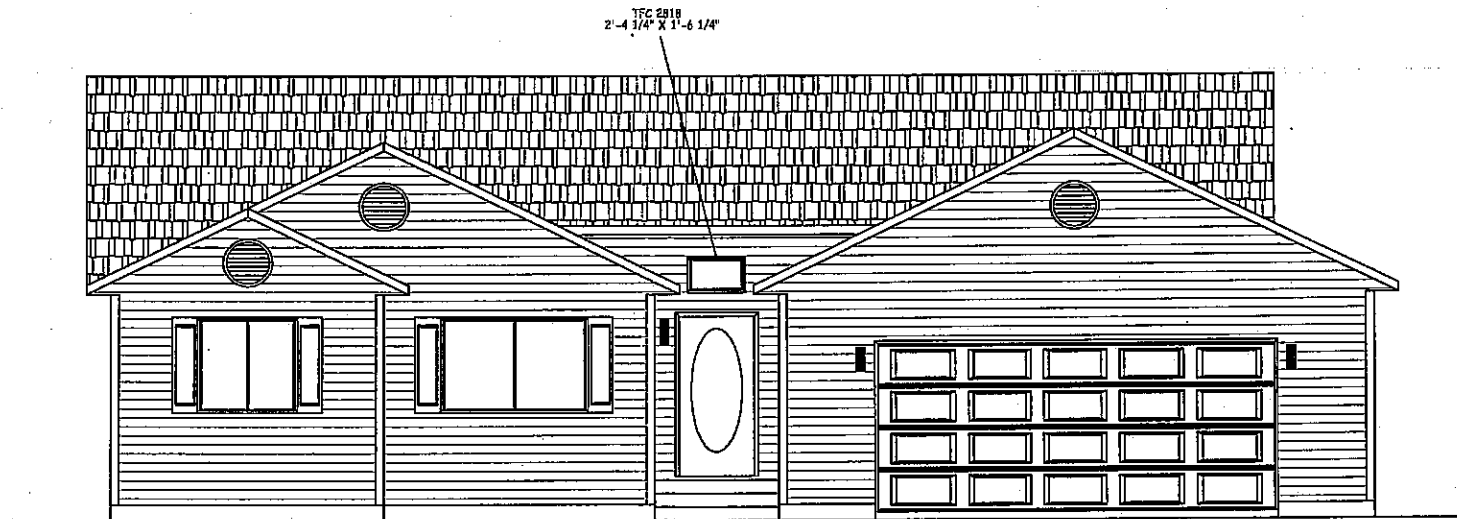

FRONT ELEVATION
1/8" = 1'-0"


HILLTOP LUMBER, Inc.		
GLENWOOD, MN (320) 634-5386		ALEXANDRIA, MN (320) 763-9663
SCALE	AS NOTED	DRAWN BY: CLINT
DATE	5-19-06	
RESIDENCE FOR:		
WEST CENTRAL - BEHRINGER		
DRAWING NUMBER		1 OF

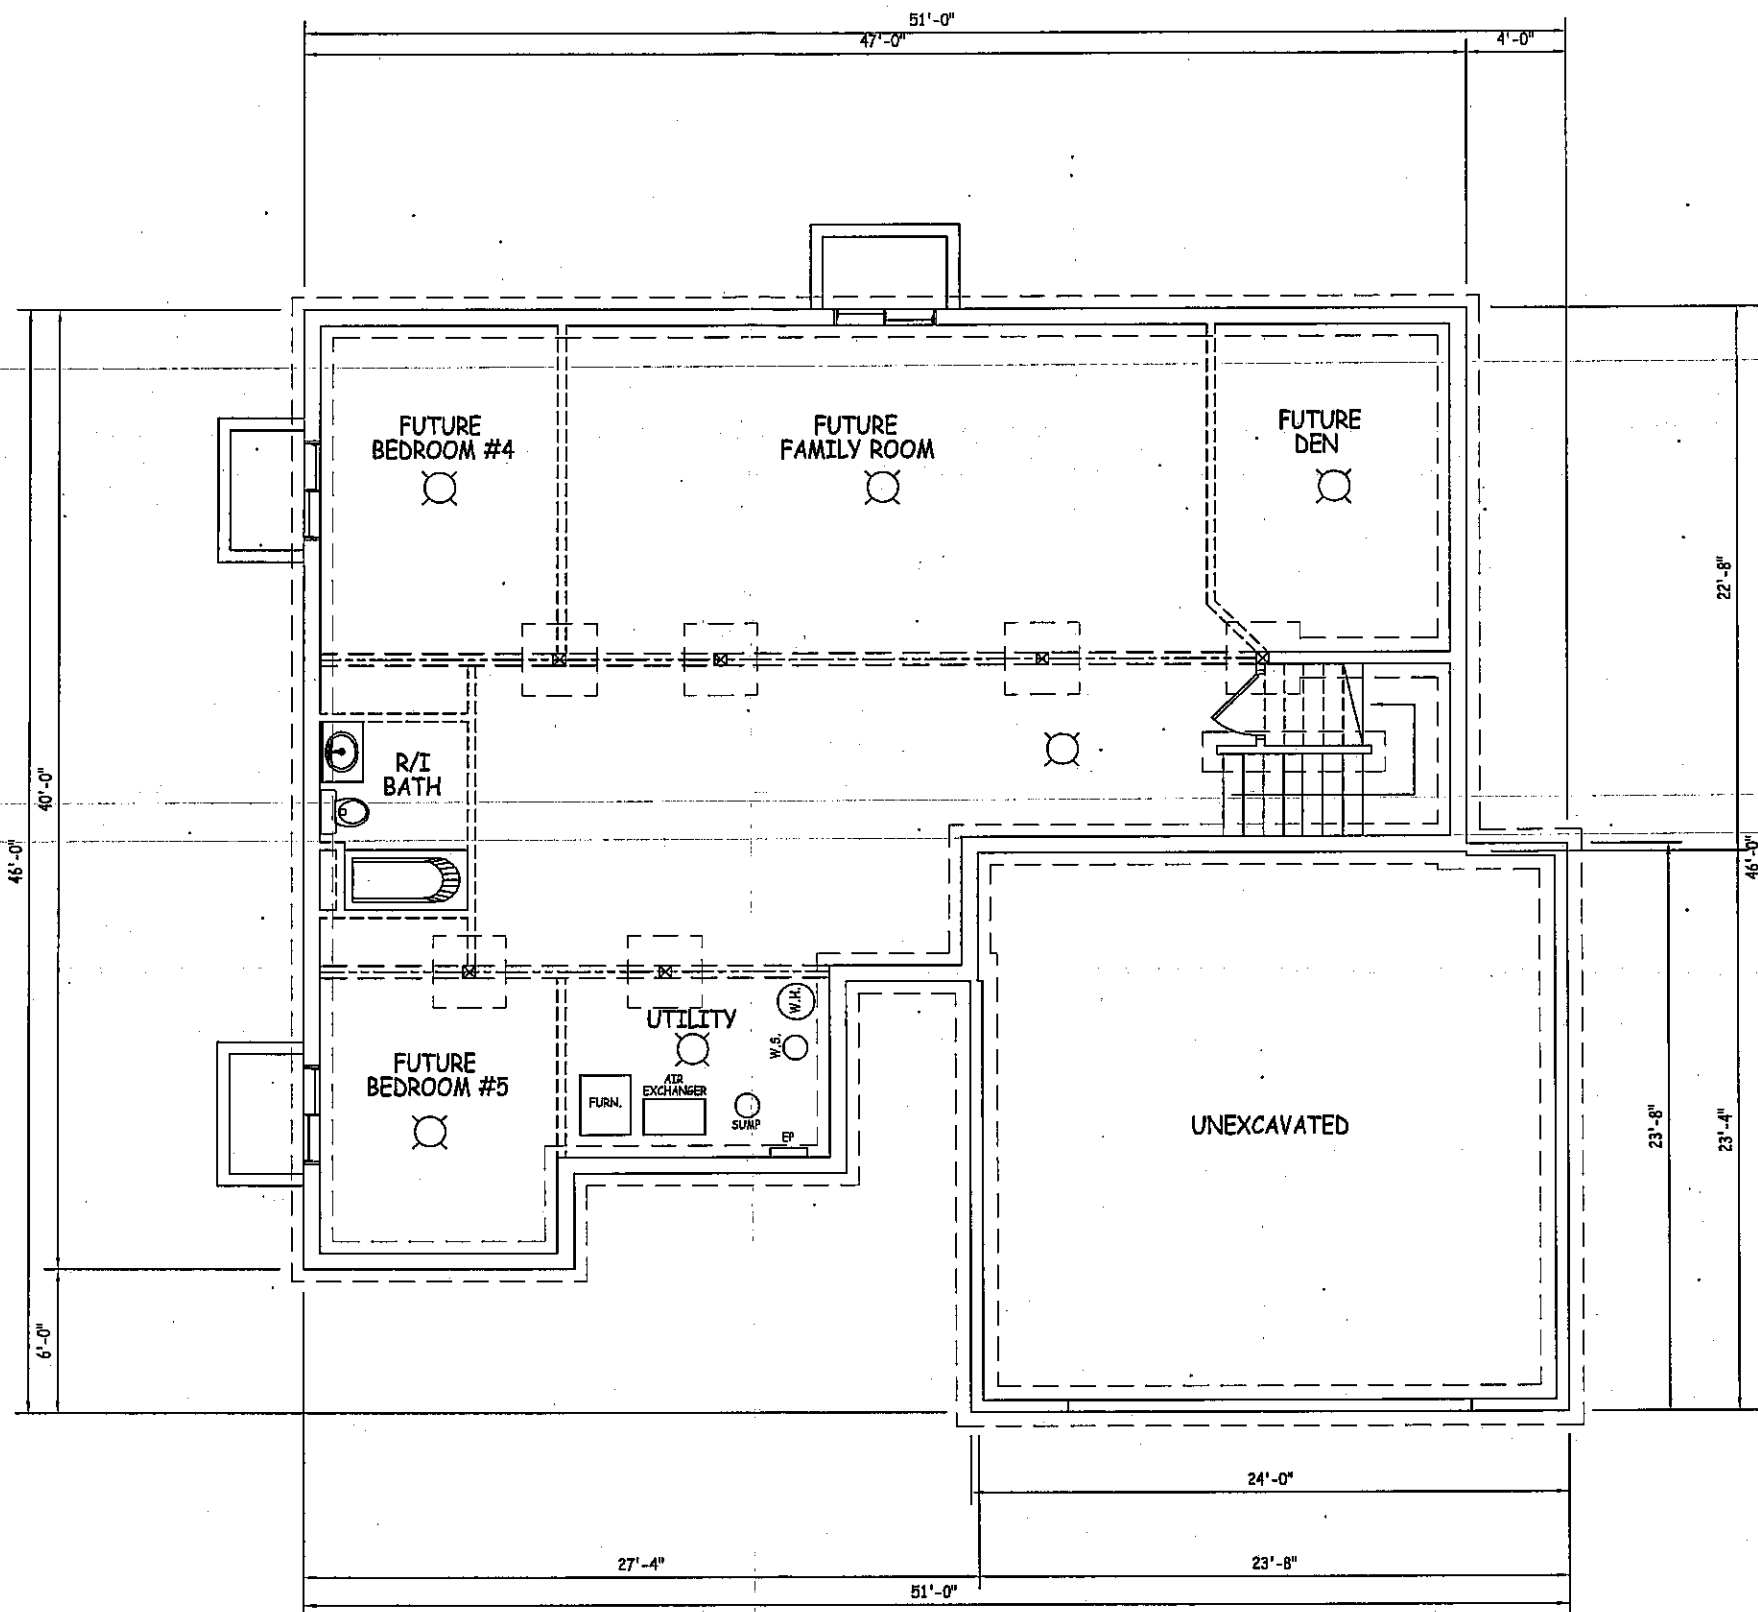

FOUNDATION ELECTRICAL PLAN

1/8" = 1'-0"

HILLTOP LUMBER, Inc.	
GLENWOOD, MN (320) 634-5386	ALEXANDRIA, MN (320) 763-9663
SCALE: AS NOTED	DRAWN BY: CLIENT
DATE: 8/16/05	
RESIDENCE FOR: WEST CENTRAL - BEHRINGER	
DRAWING NUMBER	5 OF 5

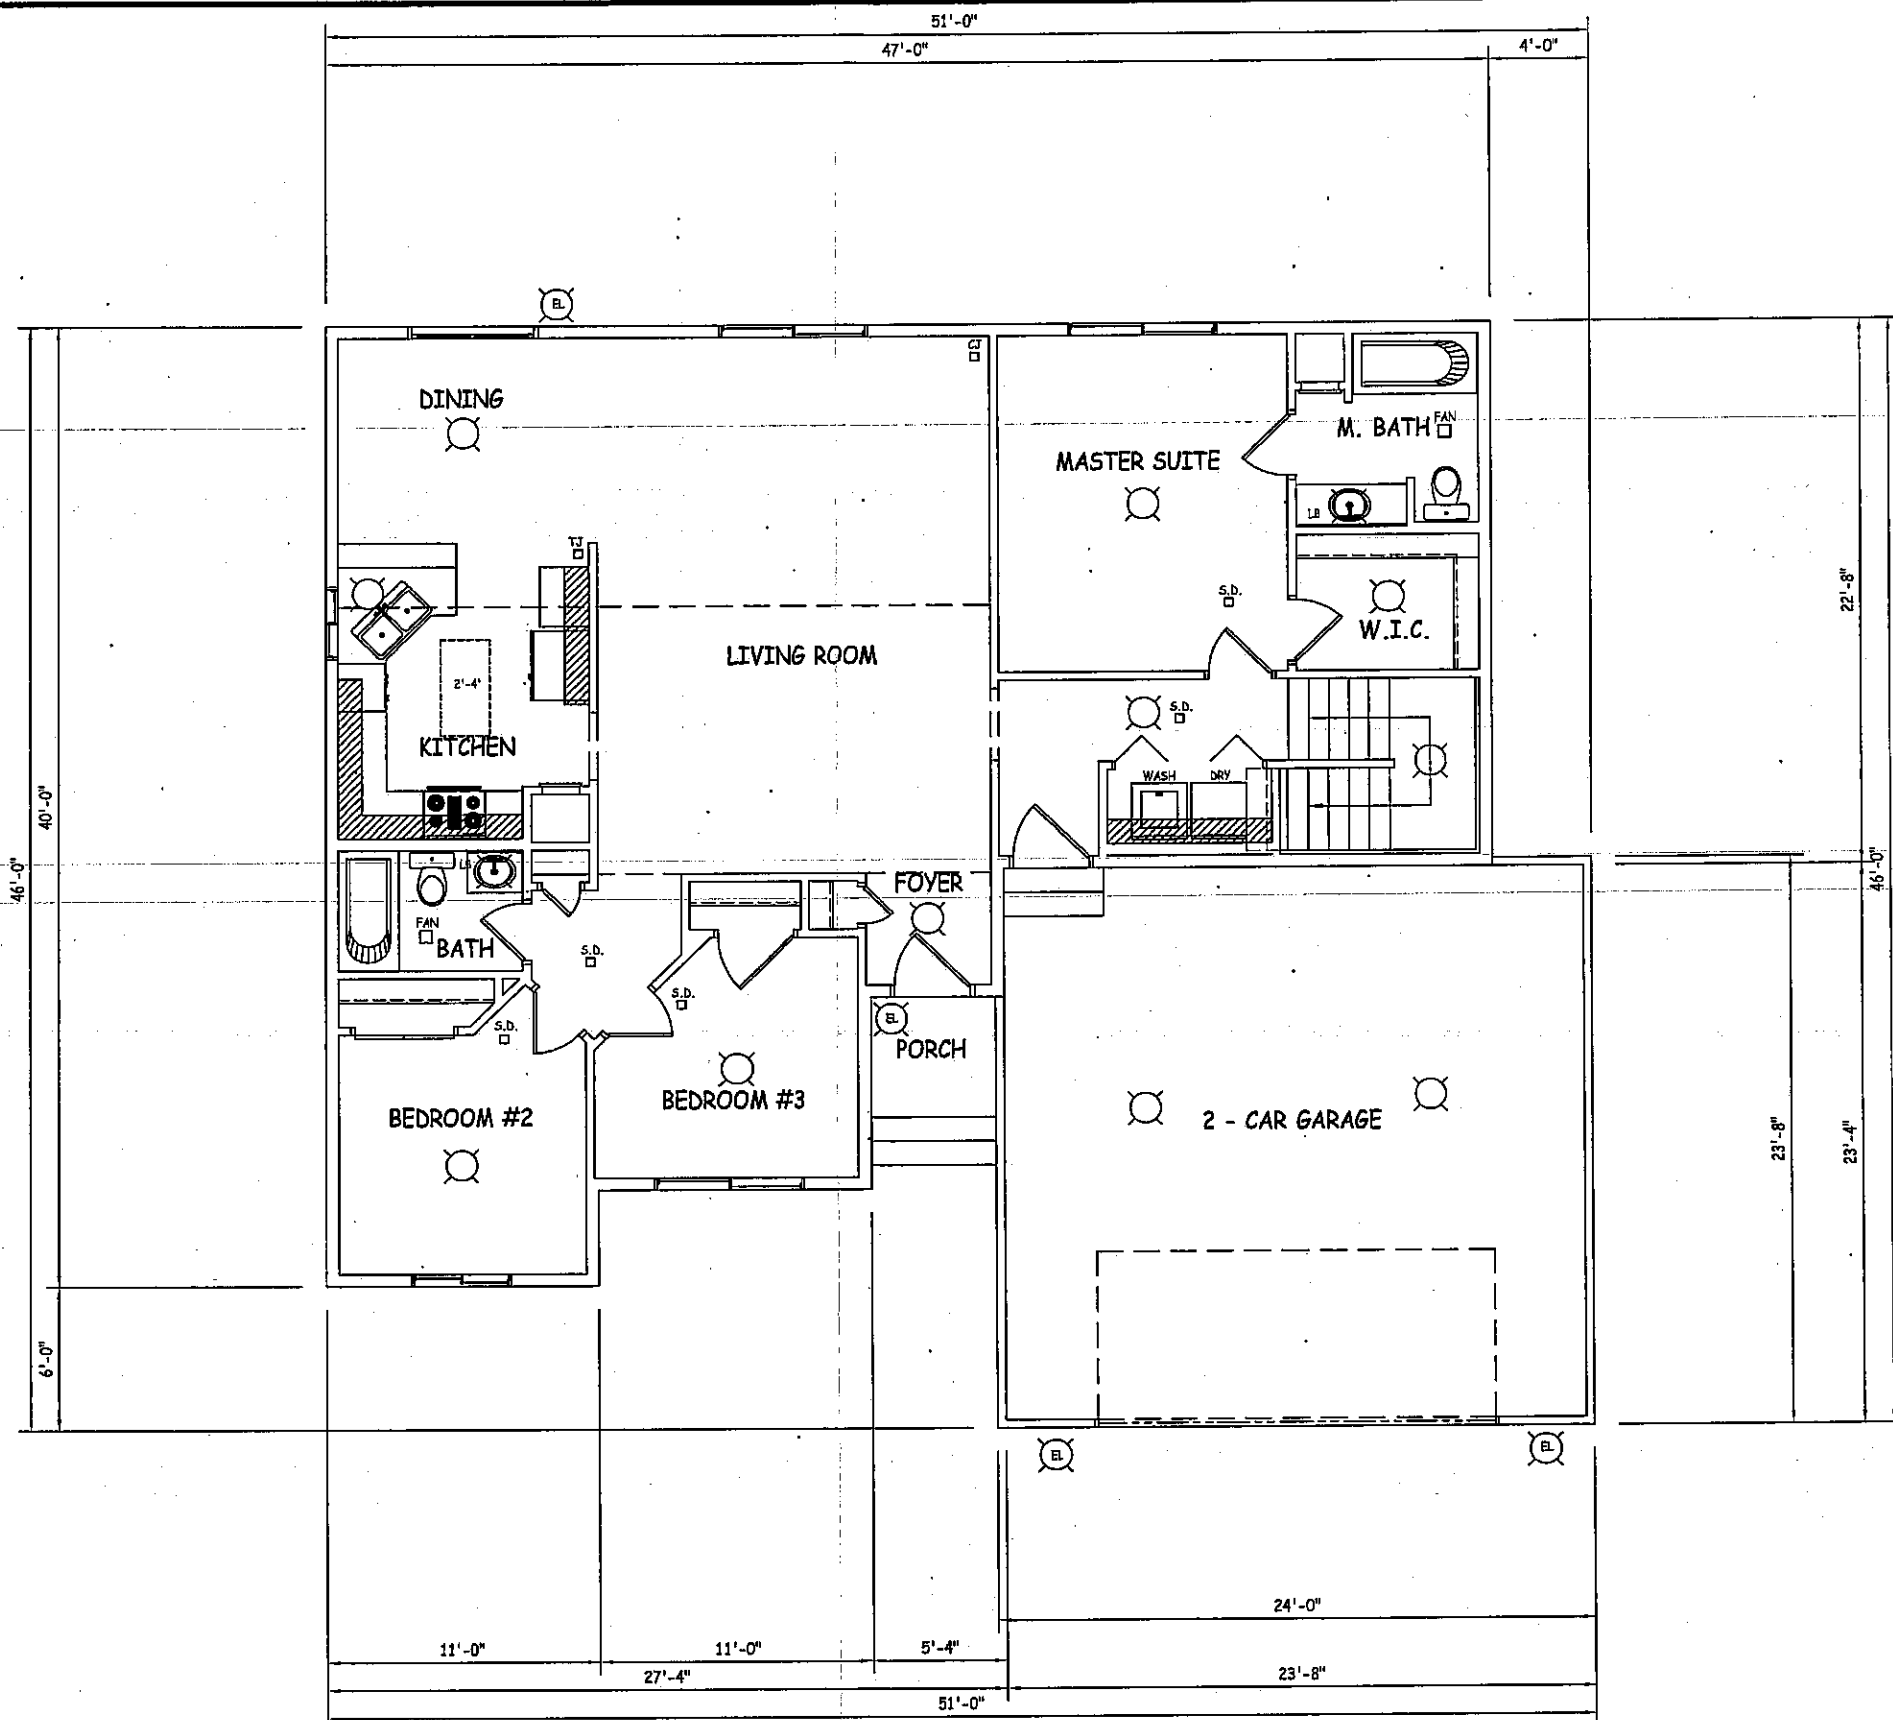

MAIN LEVEL ELECTRICAL PLAN

1/8" = 1'-0"

1408 SQ. FT.

HILLTOP LUMBER, Inc.	
GLENWOOD, MN (320) 634-5386	ALEXANDRIA, MN (320) 763-9663
SCALE: AS NOTED	DRAWN BY: CLINT
DATE: 8/16/05	
RESIDENCE FOR: WEST CENTRAL - BEHRINGER	
	DRAWING NUMBER: 6 OF 6